
 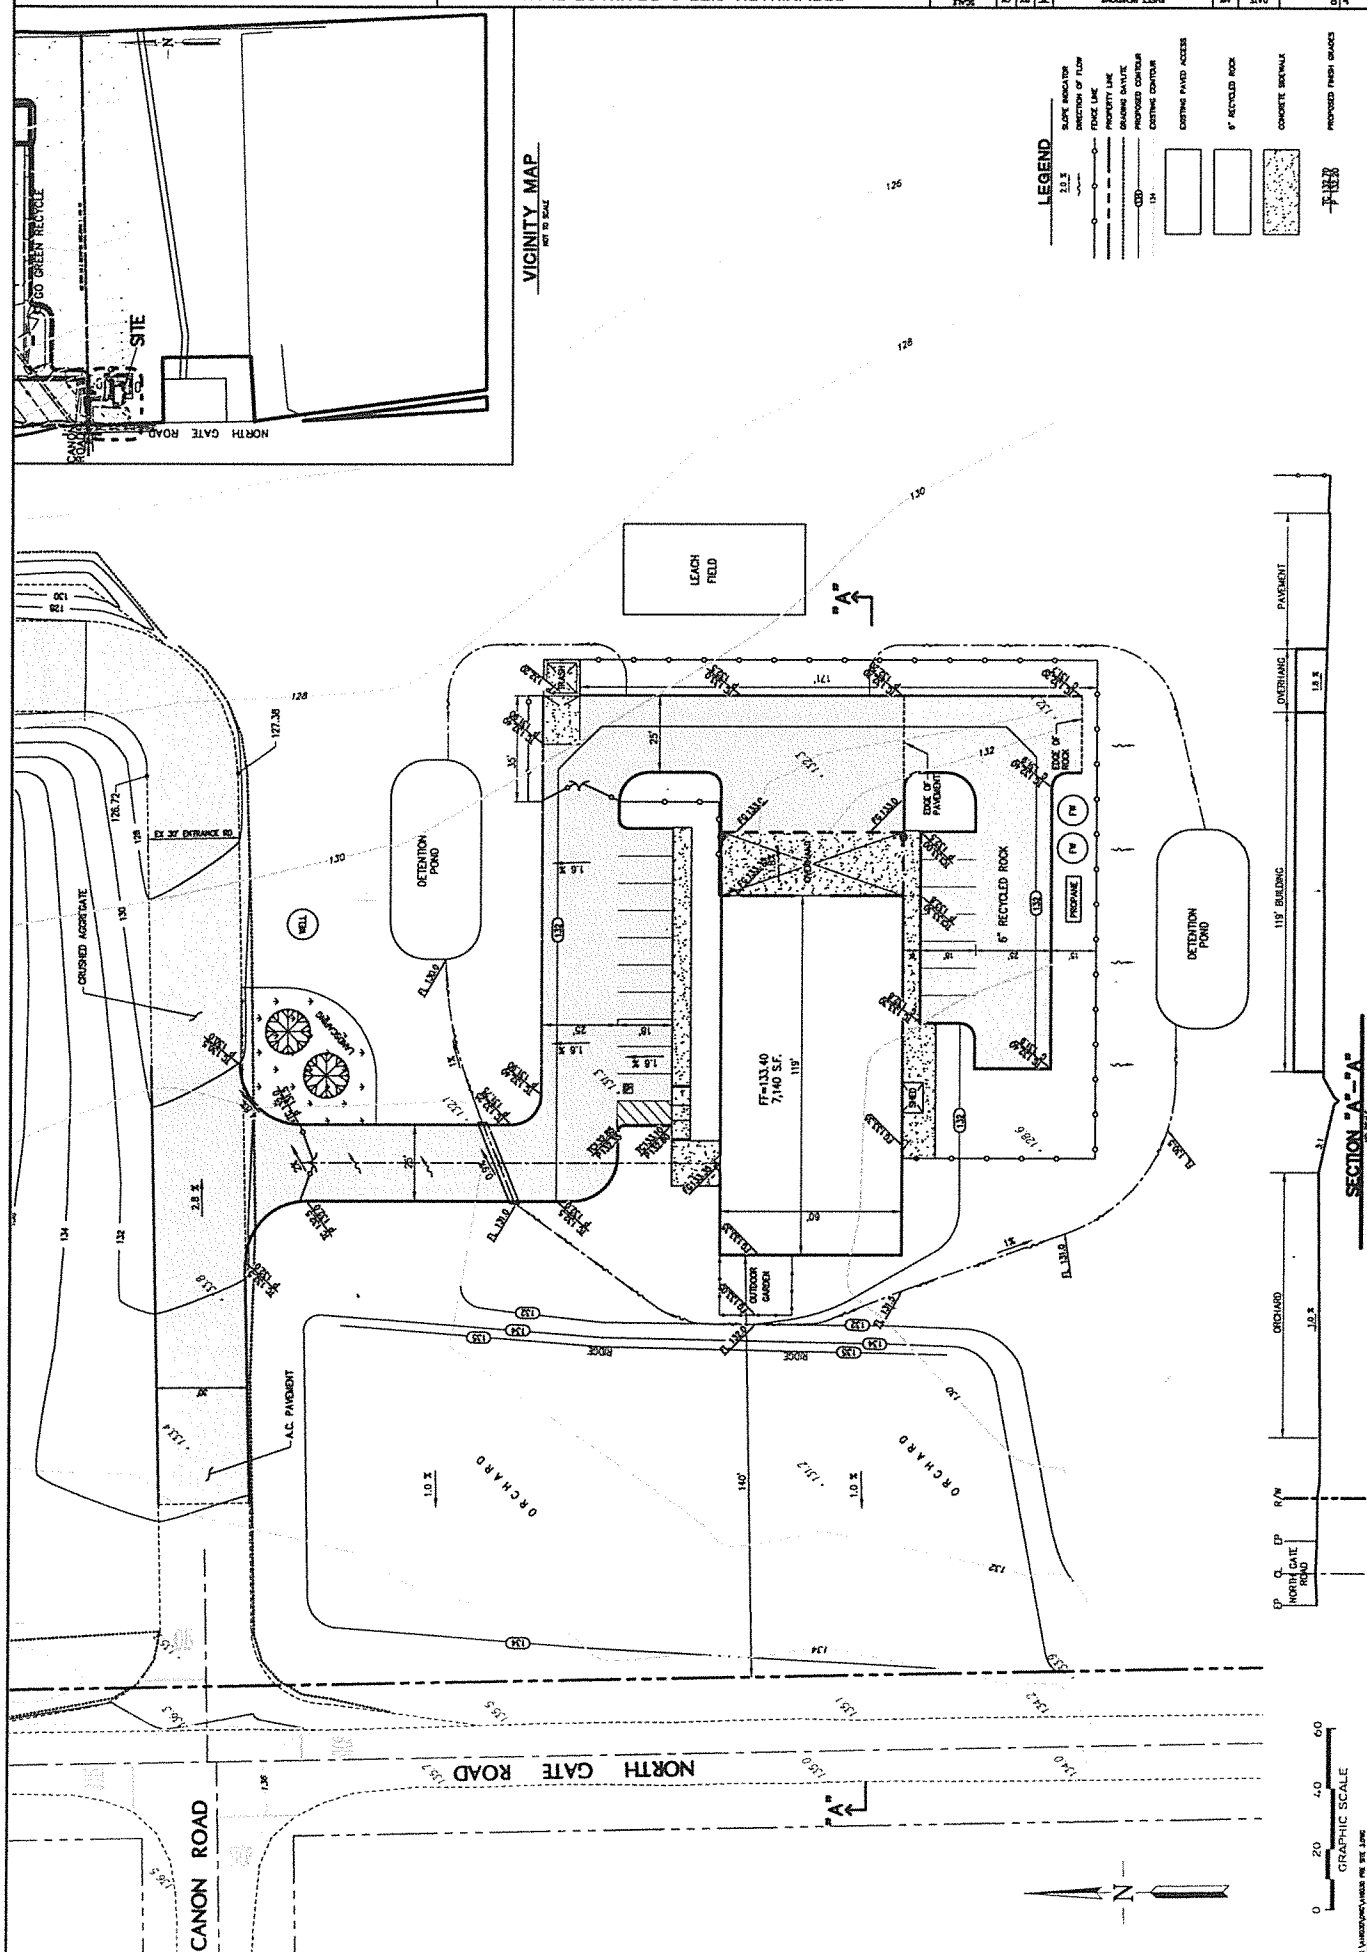


[illegible]



4111 S. Main Street, Suite 200
Fremont, CA 94536
www.pdtinc.com


REVISIONS

**BUBBLING WELL MEMORIAL
PET CREMATORIUM PROJECT**
North Gate Road, Solano County, California



Project: Bubbling Well Memorial
Drawing: 207

Sheet Number: A-11

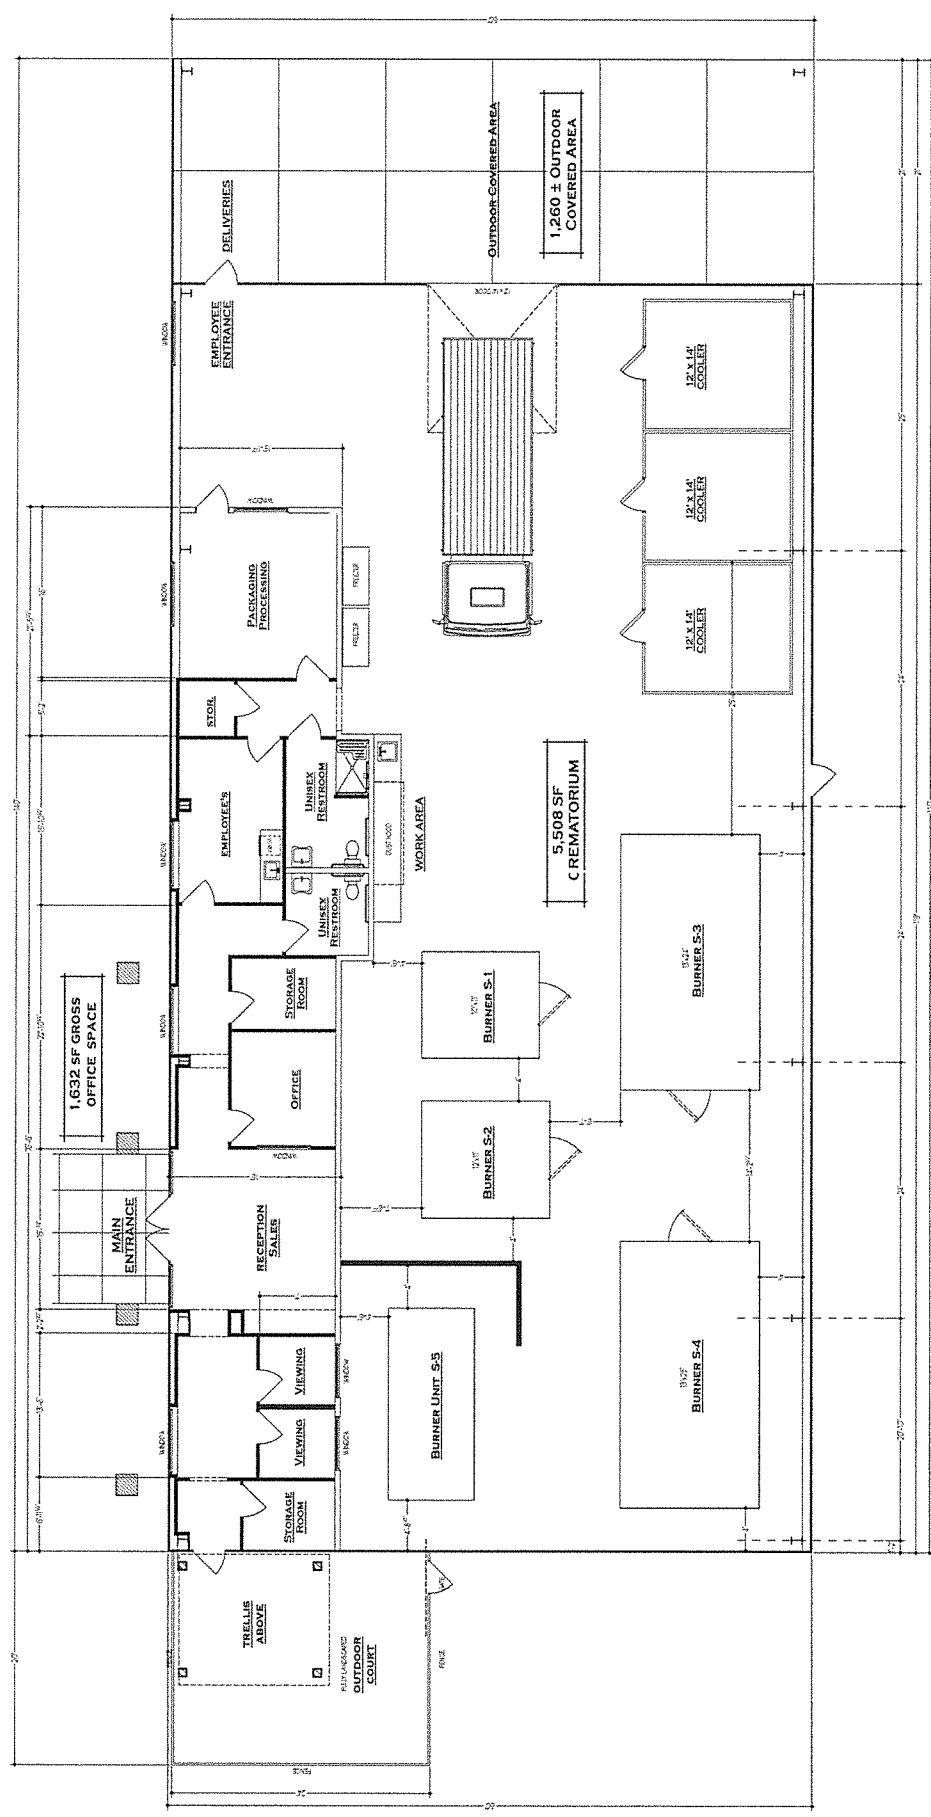

FLOOR PLAN
Scale: 3/8" = 1'-0"



Revisions

Sheet number
A-2.1

